



FRONT ELEVATION
SCALE: 1/4" = 1'-0"


NOTE:
ALL INTERIOR CONCRETE BLOCK WALLS
ARE DETAILED AT 8" BLOCK WALLS.

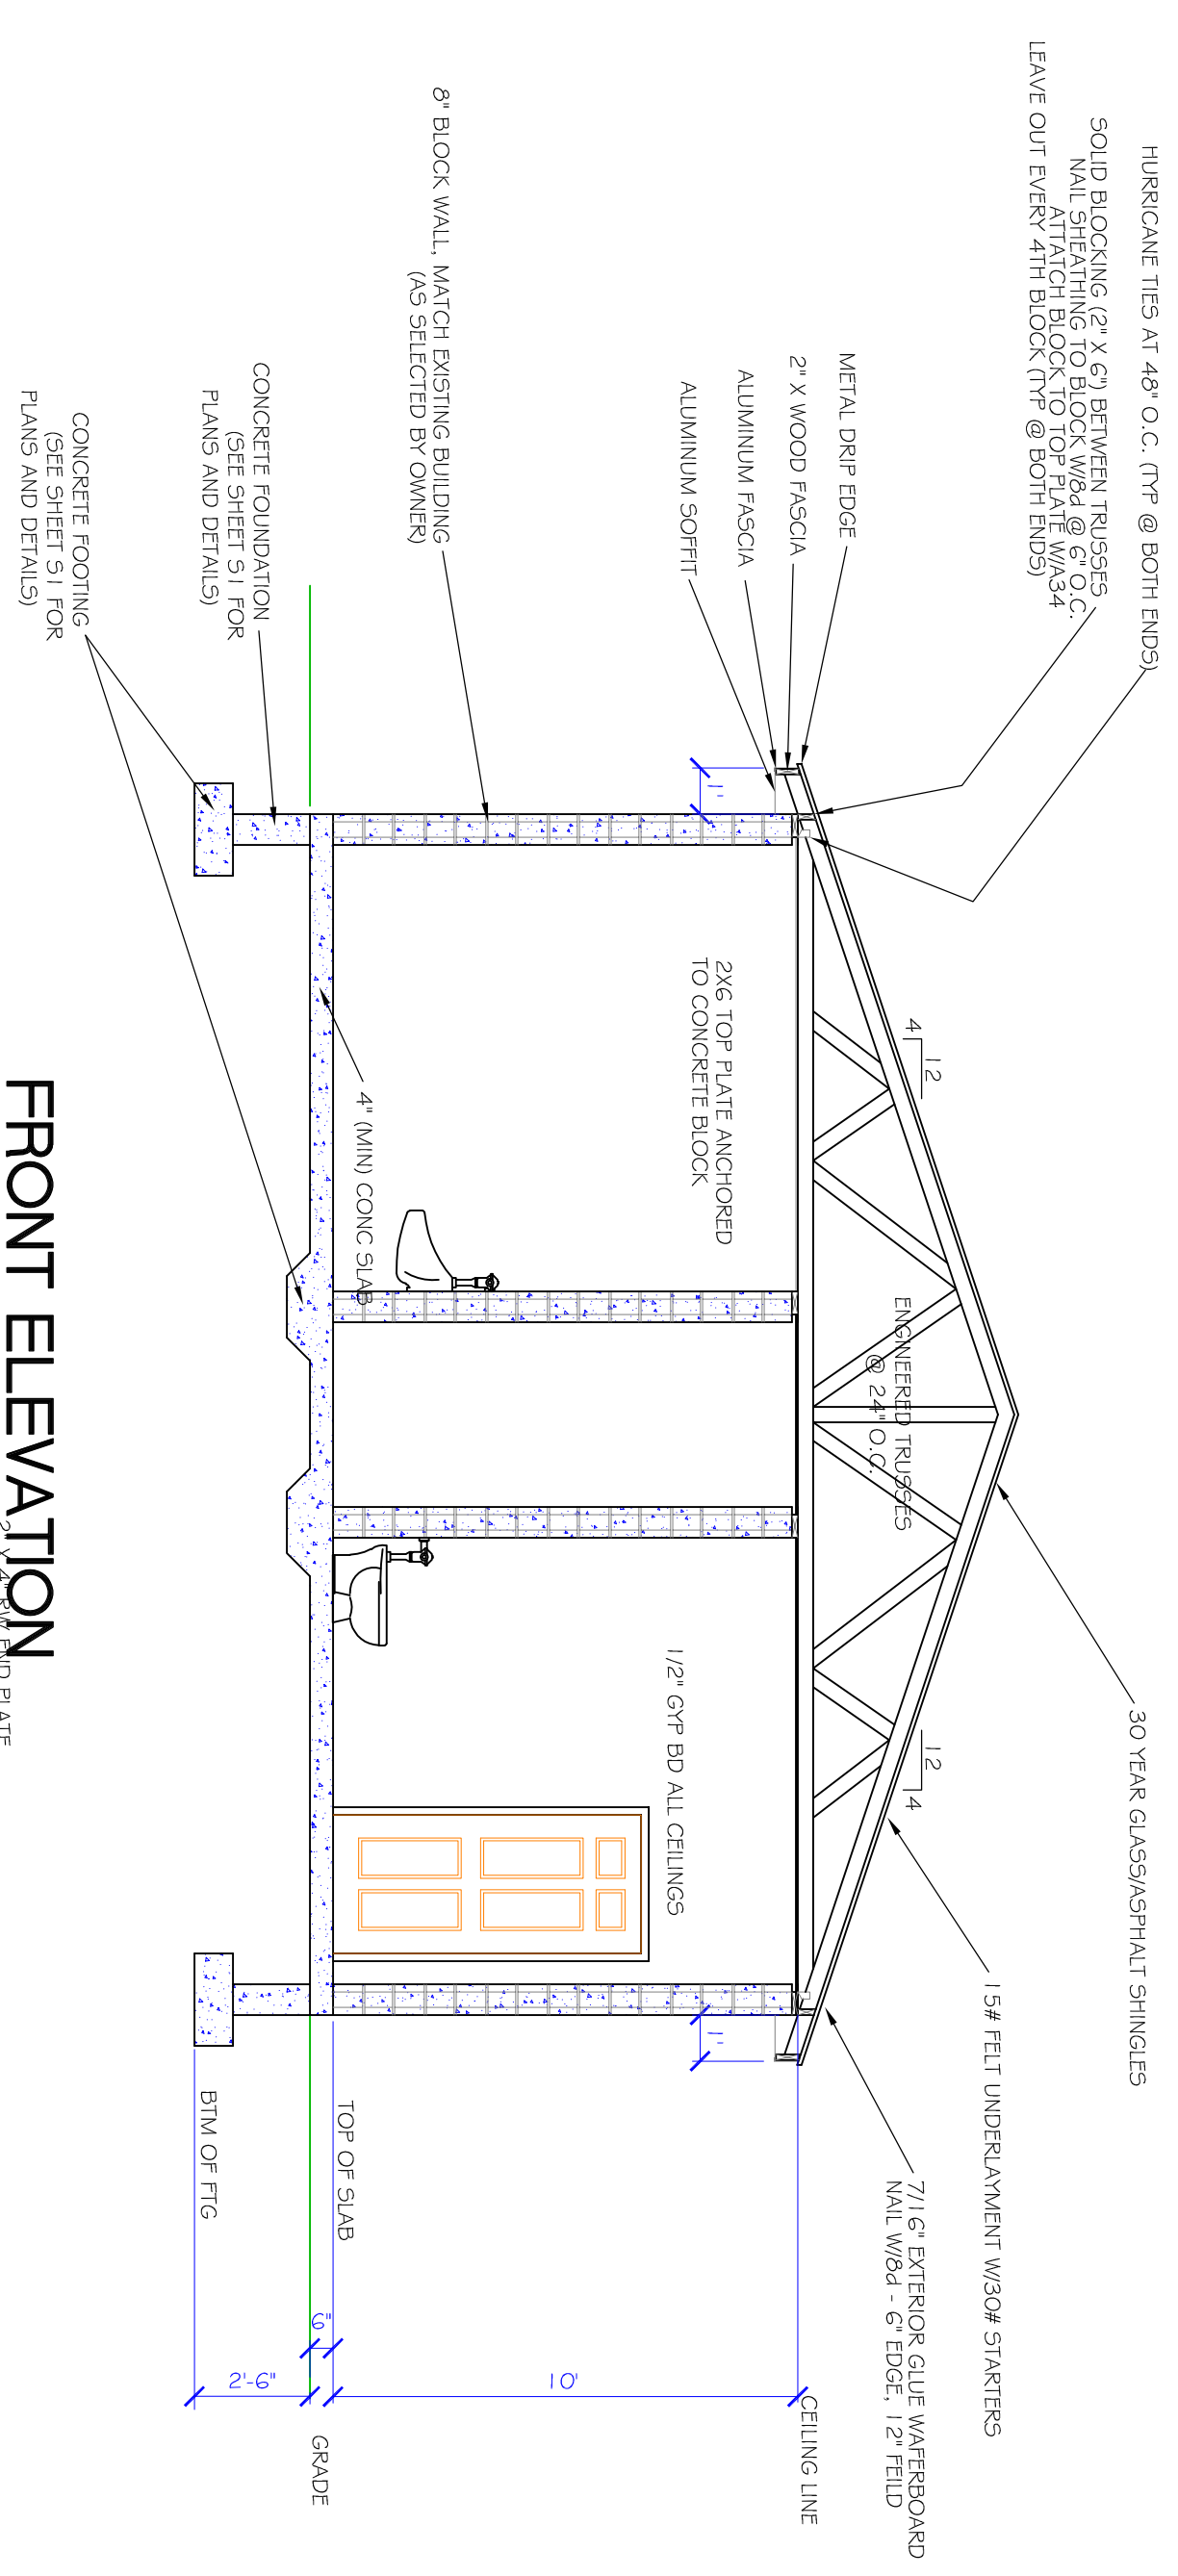


FRONT ELEVATION
SCALE: 1/4" = 1'-0"

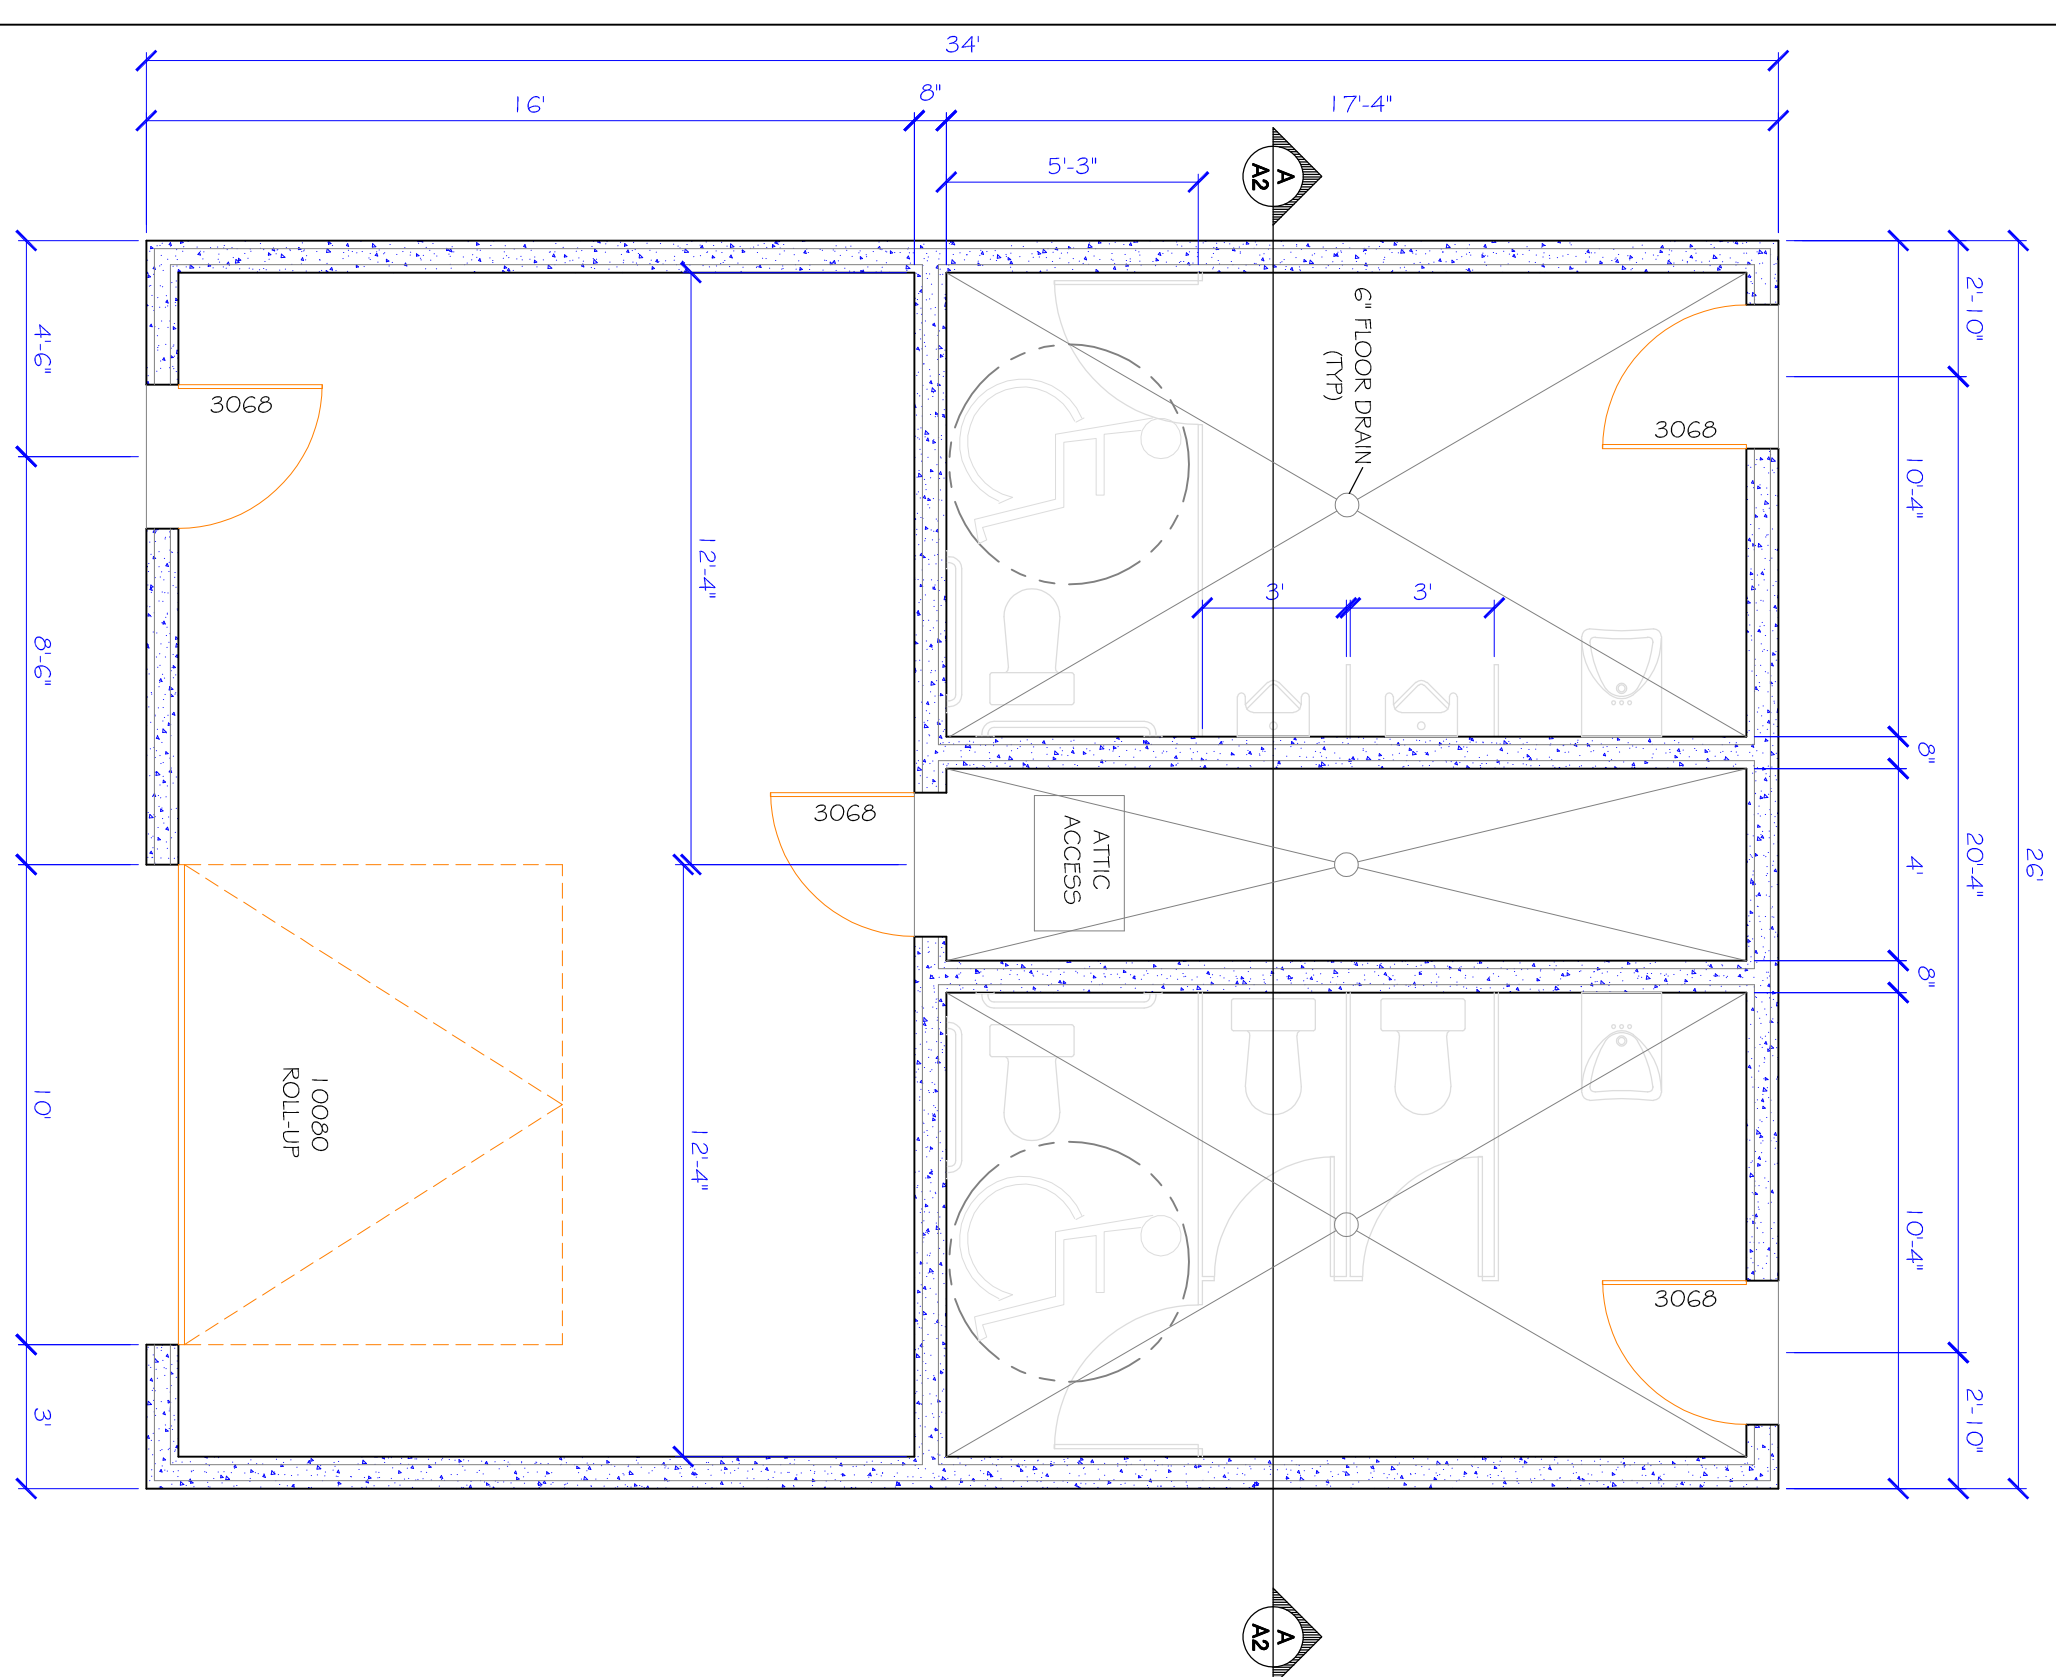


MAIN LEVEL FLOOR PLAN
SCALE: 1/4" = 1'-0"

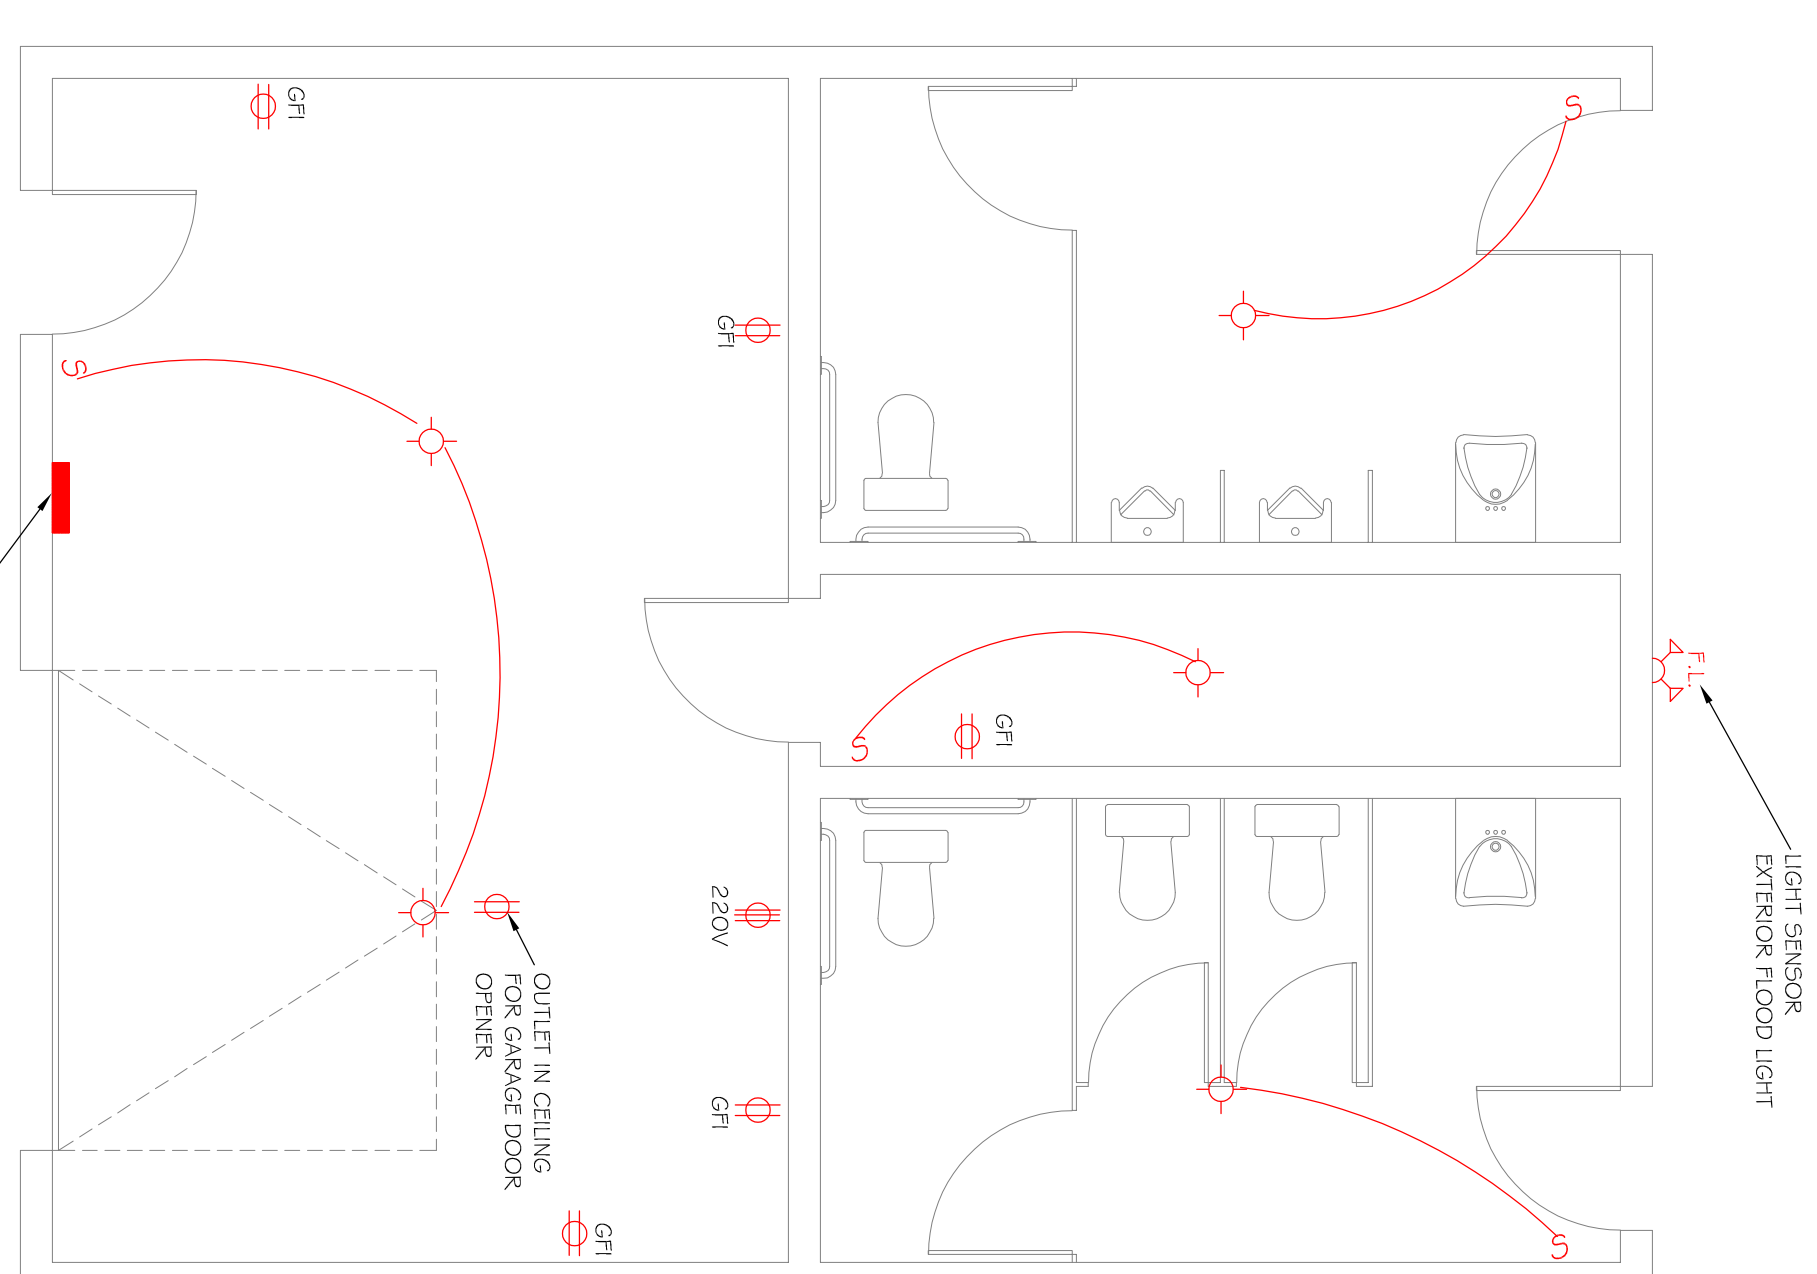

ELECTRICAL PLAN
SCALE: 1/4" = 1'-0"

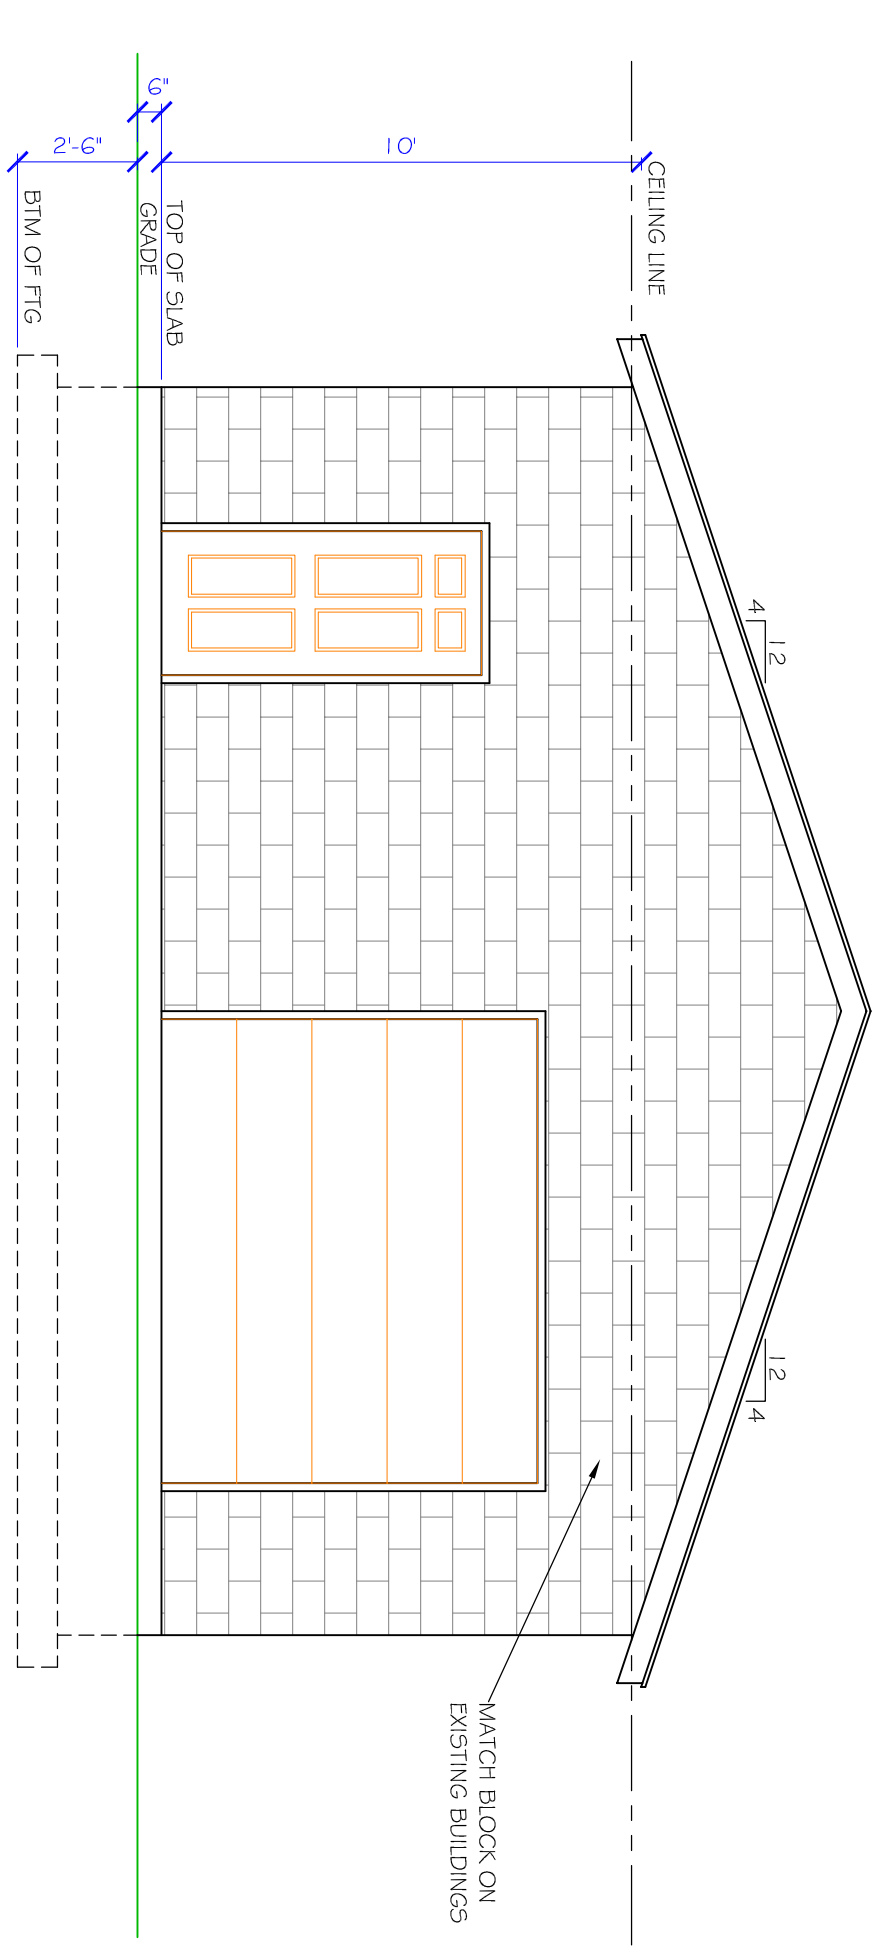

REAR ELEVATION
SCALE: 1/4" = 1'-0"

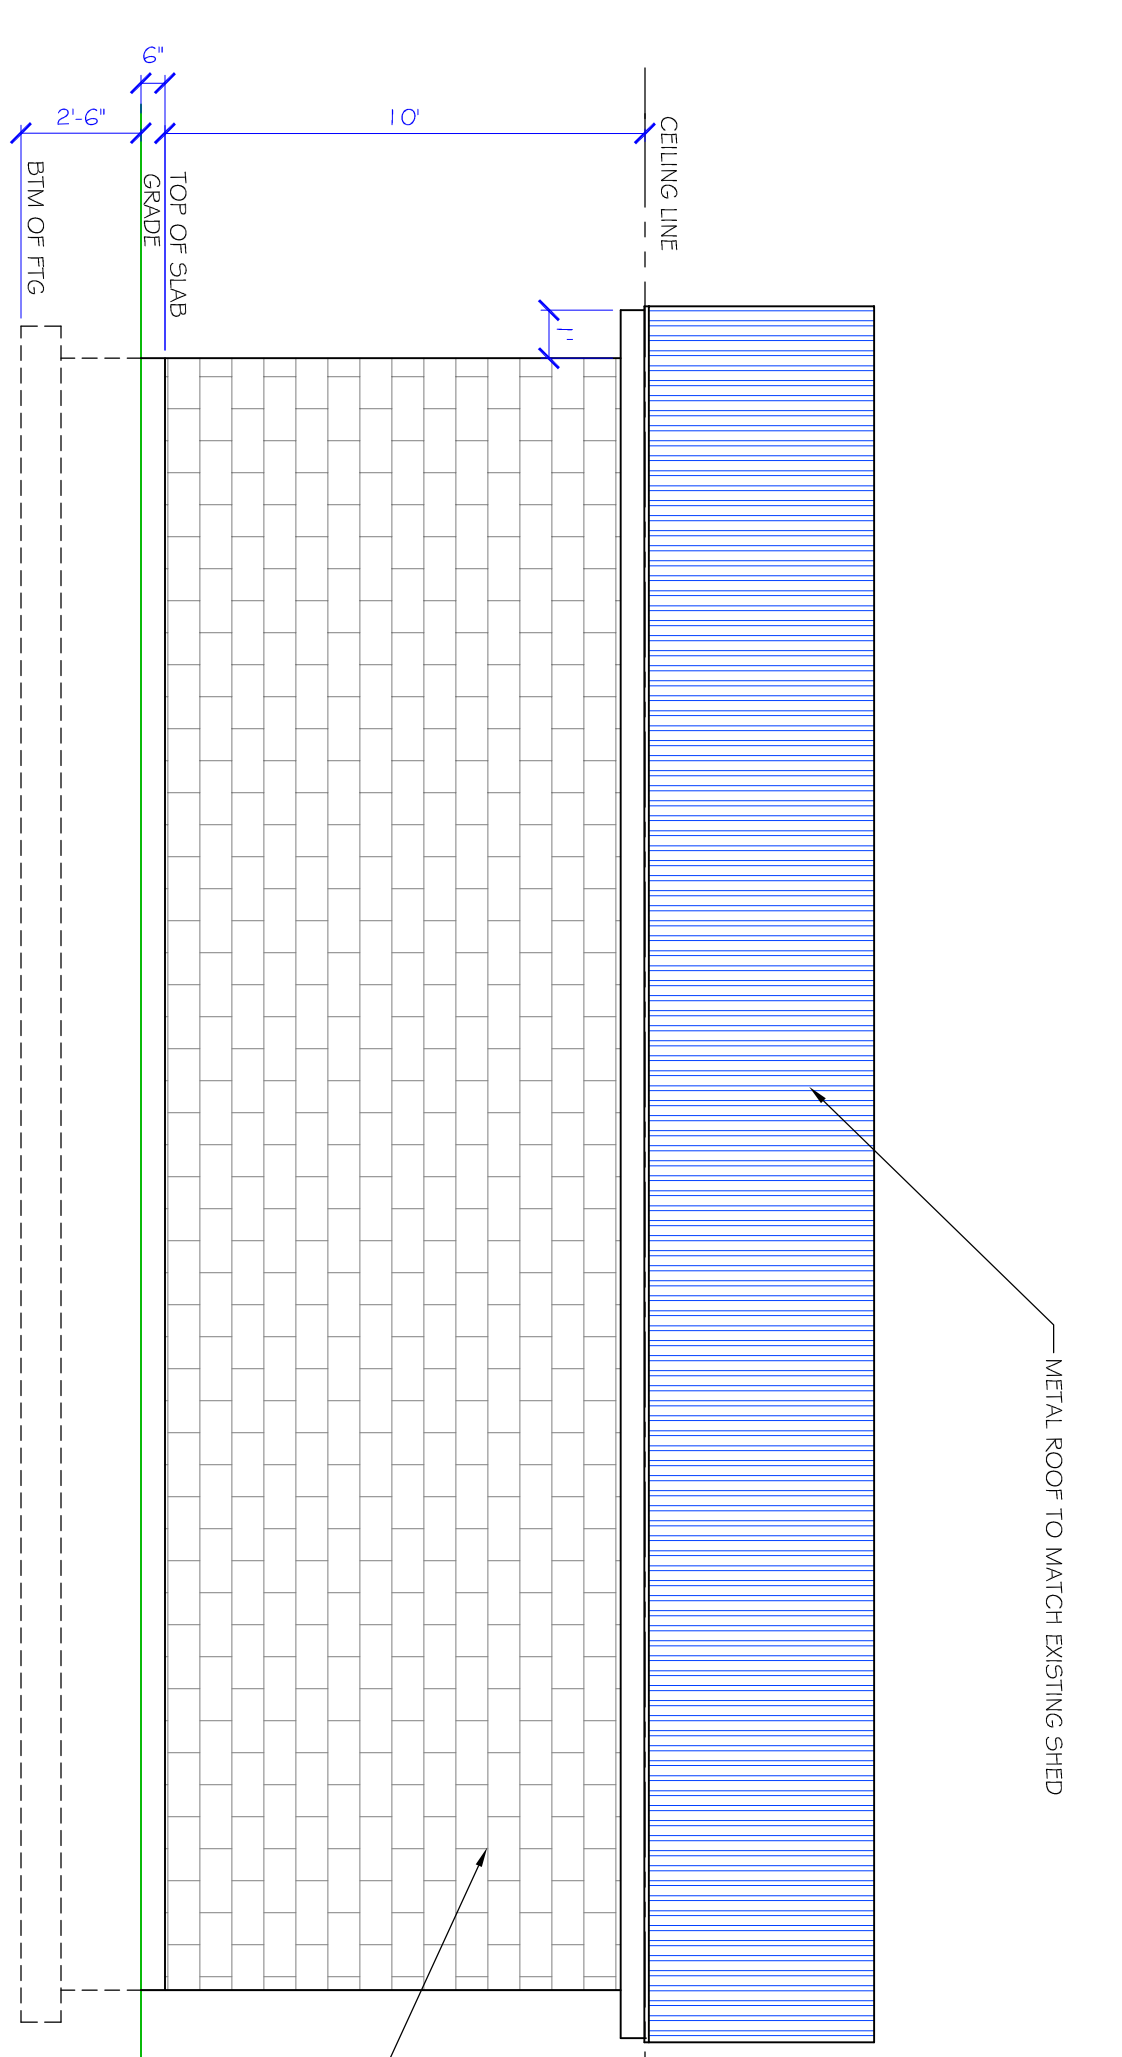

LEFT AND RIGHT SIDE ELEVATION
SCALE: 1/4" = 1'-0"

NO.	DATE	DESCRIPTION

FILE NAME	5/24/21
DATE	5/24/21
NO. OF SHEETS	2 of xx
SHEET NO.	A2

PLANS AND ELEVATIONS	
SALEM REC RESTROOM	
X	X
X	X
X	X

L & L DESIGNS
 3355 WEST 7900 SOUTH
 BENJAMIN, UT 84660
 TELE: (801) 798-0707
 FAX: (801) 798-0707
 Ddlundell@AOL.COM